


Primary School  
School

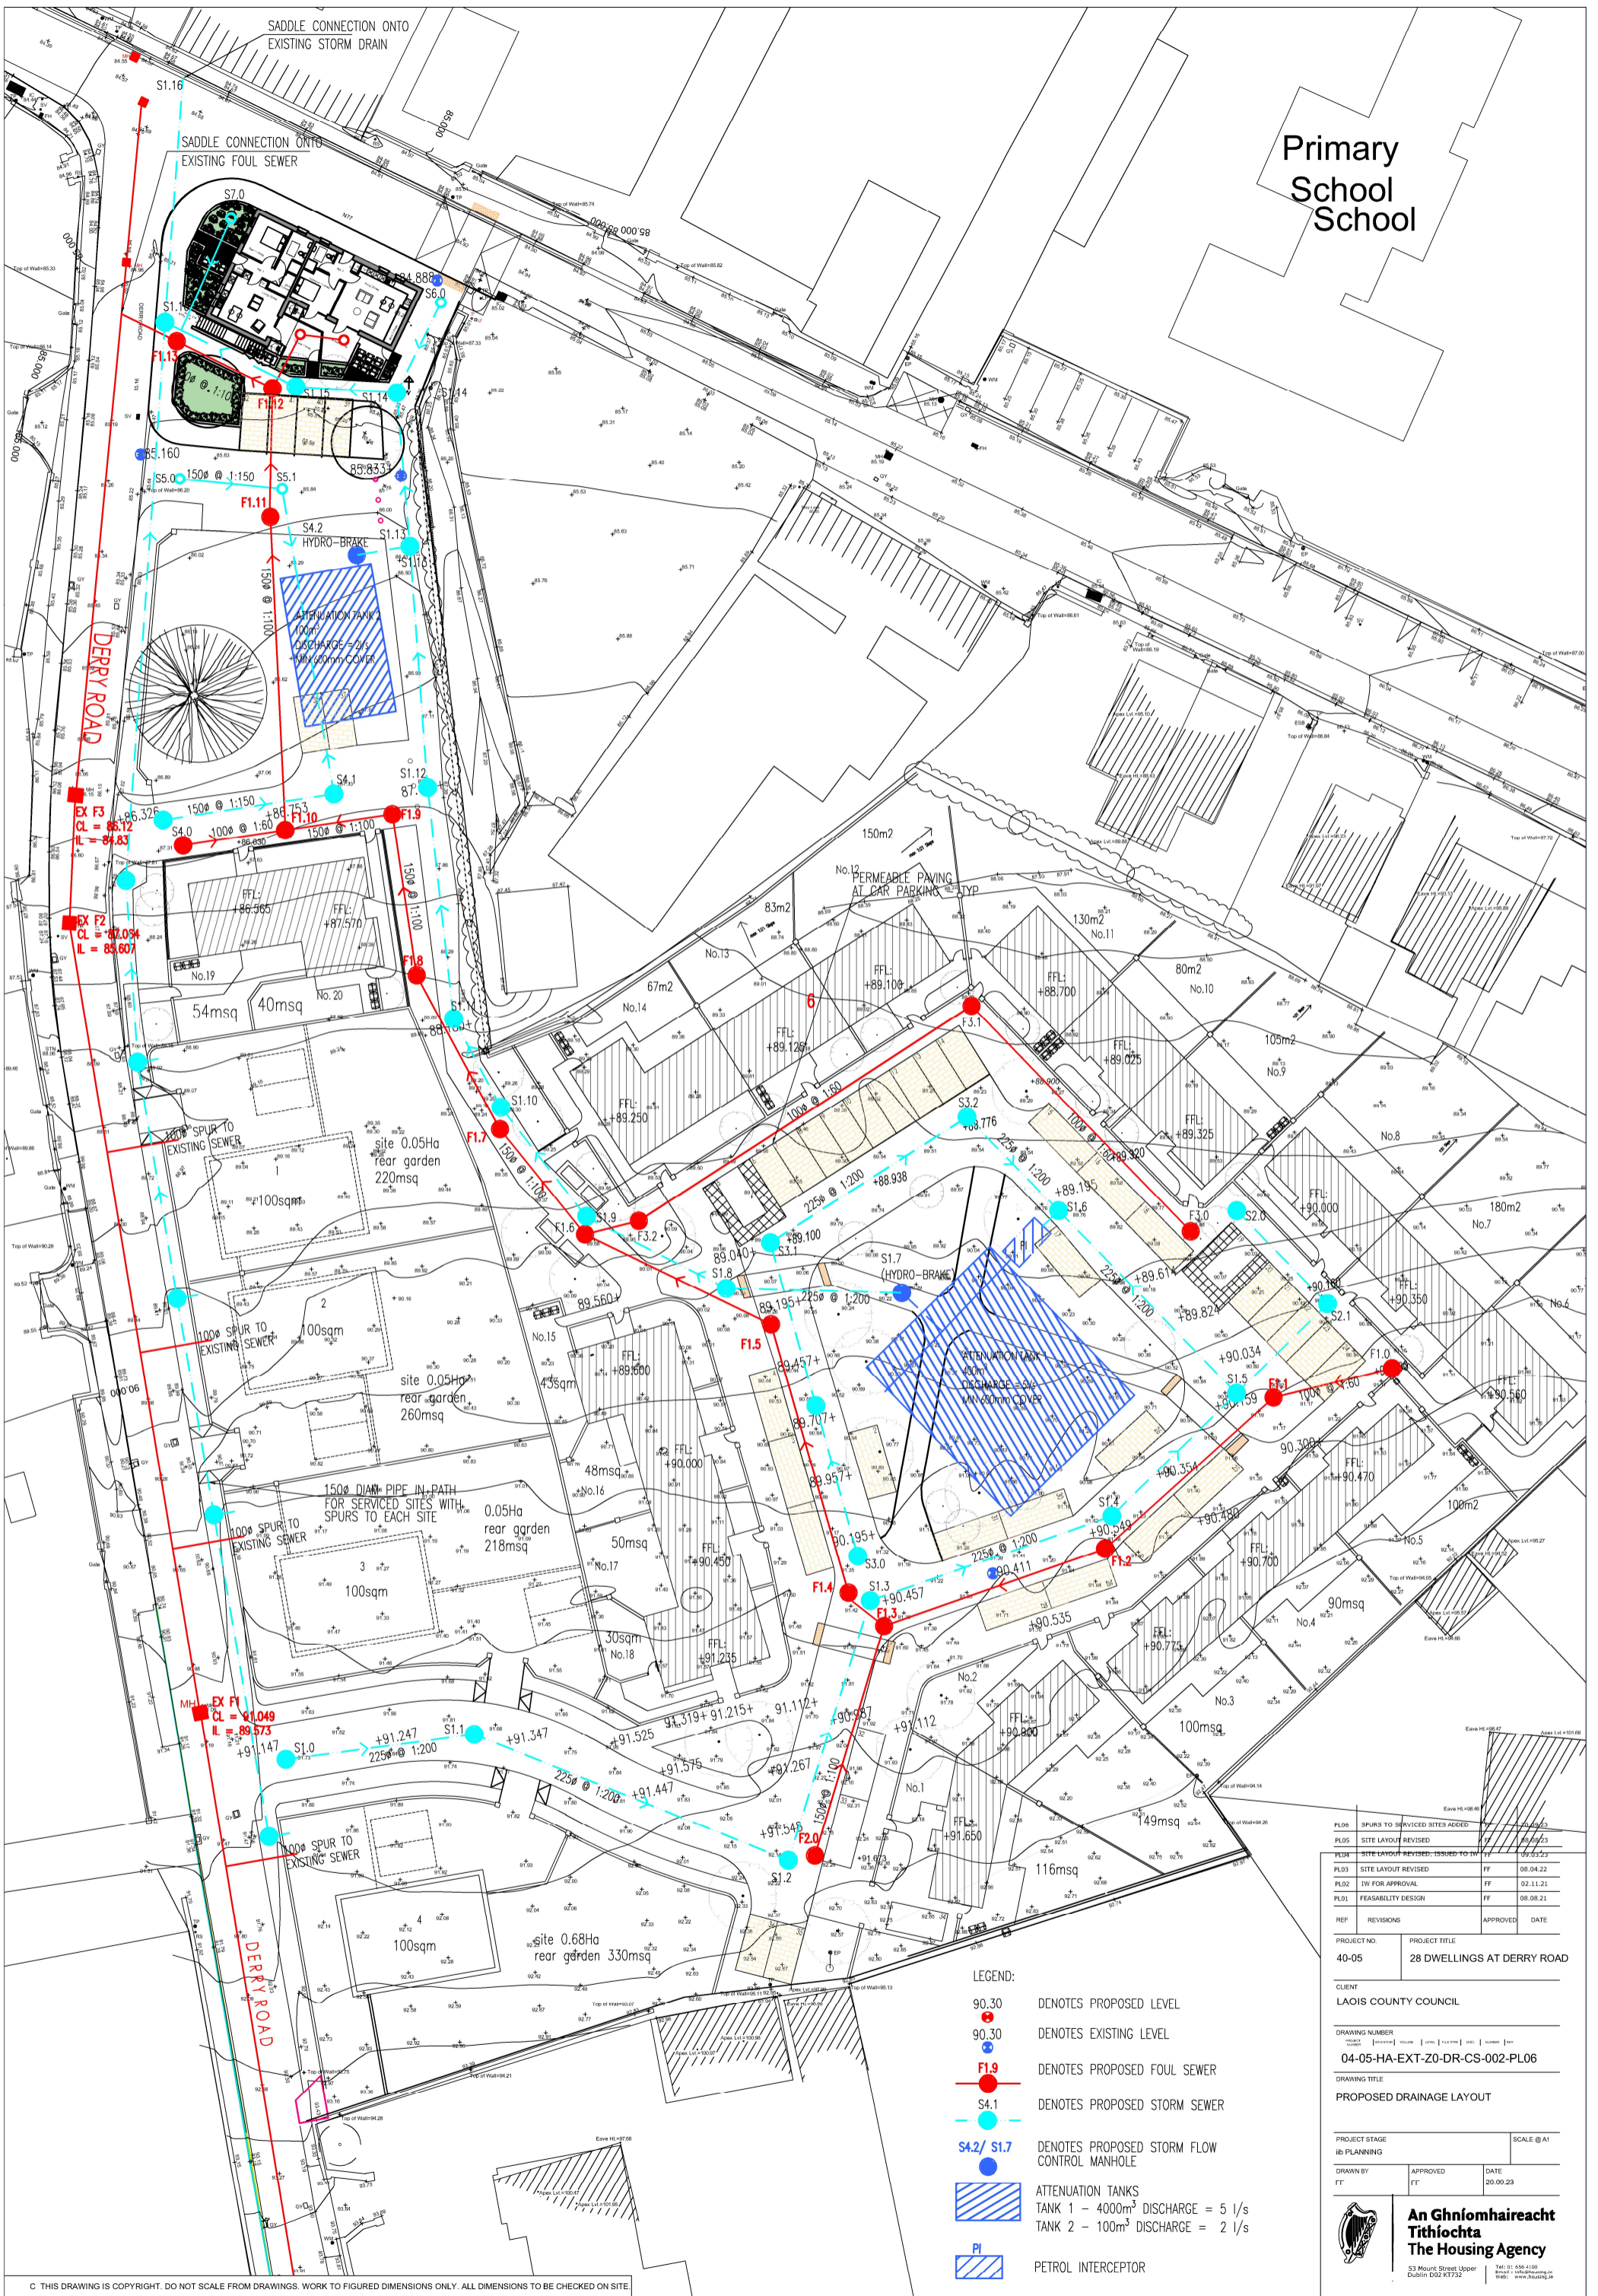

PL06	SPURS TO SERVICED SITES ADDED	FF	08.04.22
PL05	SITE LAYOUT REVISED	FF	08.04.22
PL04	SITE LAYOUT REVISED - ISSUED TO IW	FF	08.04.22
PL03	SITE LAYOUT REVISED	FF	08.04.22
PL02	IW FOR APPROVAL	FF	02.11.21
PL01	FEASIBILITY DESIGN	FF	08.08.21

PROJECT NO: 40-05  
PROJECT TITLE: 28 DWELLINGS AT DERRY ROAD

CLIENT: LAOIS COUNTY COUNCIL

DRAWING NUMBER: 04-05-HA-EXT-Z0-DR-CS-002-PL06

DRAWING TITLE: PROPOSED DRAINAGE LAYOUT

PROJECT STAGE	SCALE @ A1
IB PLANNING	
DRAWN BY: FT	APPROVED: FT
DATE: 20.09.23	

**An Ghníomhaireacht Tithíochta**  
**The Housing Agency**

53 Mount Street, Upper Dublin D02 KT32  
Tel: 01 850 4100  
www.housing.gov.ie

- LEGEND:**
- 90.30 DENOTES PROPOSED LEVEL
  - 91.30 DENOTES EXISTING LEVEL
  - F1.9 DENOTES PROPOSED FOUL SEWER
  - S4.1 DENOTES PROPOSED STORM SEWER
  - S4.2/ S1.7 DENOTES PROPOSED STORM FLOW CONTROL MANHOLE
  - ATTENUATION TANKS  
TANK 1 - 4000m<sup>3</sup> DISCHARGE = 5 l/s  
TANK 2 - 100m<sup>3</sup> DISCHARGE = 2 l/s
  - PI PETROL INTERCEPTOR